

**PROPOSED NEW
RELOCATABLE
CLASSROOM
LOCATIONS
CLOUDED IN RED**

**EXISTING
RELOCATABLE
CLASSROOM
UNITS**

ACCESS FOR
TRUCKS
CLASSROOMS

 


MABEE ROAD



| NO. | REVISION | DATE |
|-----|----------|------|
| | | |
| | | |
HAGGETT ENGINEERING ASSOCIATES, INC.
 5307 SOUTH COLLEGE ROAD, SUITE 2B
 WILMINGTON, NORTH CAROLINA 28412
 PHONE: (910) 397-0608
 LICENSE NO.: C-1111



DRAWING:
C.1.0

MURRAYVILLE ELEMENTARY SCHOOL
 225 MABEE WAY
 WILMINGTON, NORTH CAROLINA 28411
 2016 AERIAL IMAGE SITE PLAN
 DESIGN: DOUG HAGGETT
 CHECKED BY: []
 DATE: 15NOV2017
 SCALE: AS SHOWN

PANEL LOCATIONS SHOWN FOR REFERENCE ONLY. FINAL LOCATIONS TO BE DETERMINED IN COORDINATION WITH OWNER

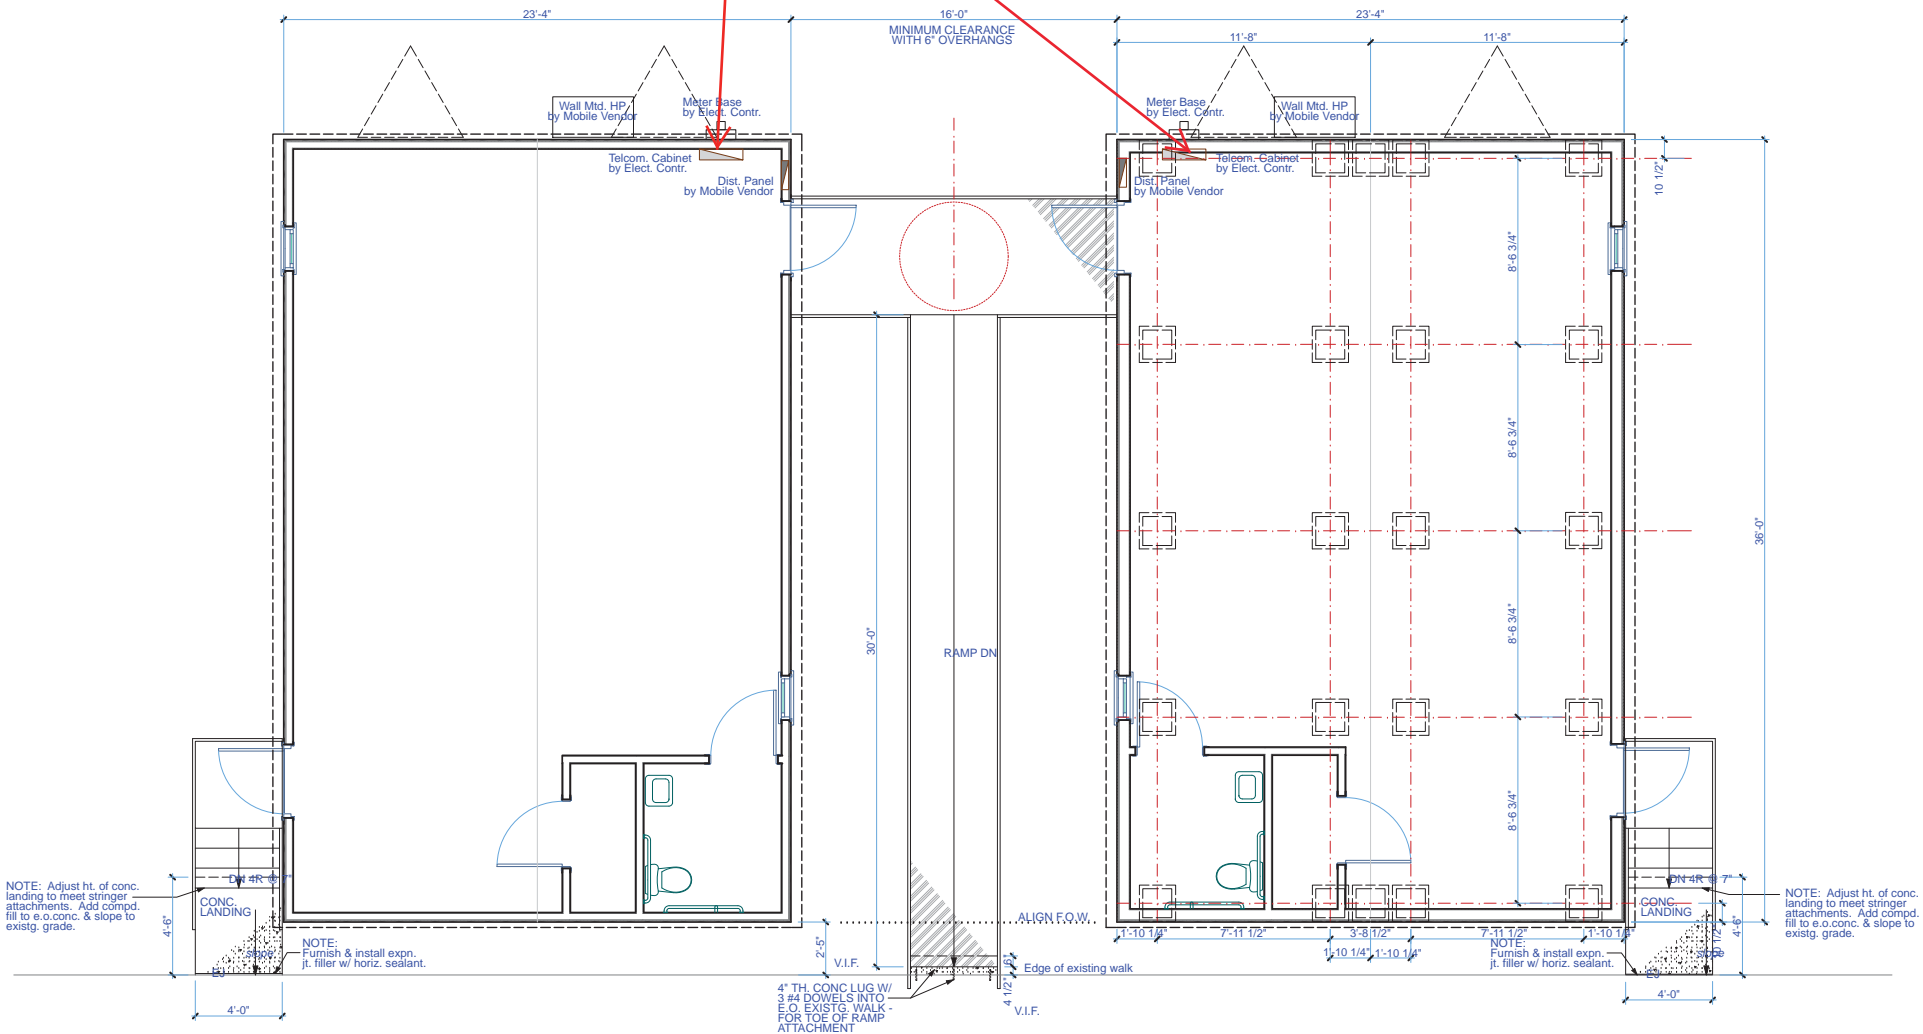

MURRAYVILLE

